


1 SR Section

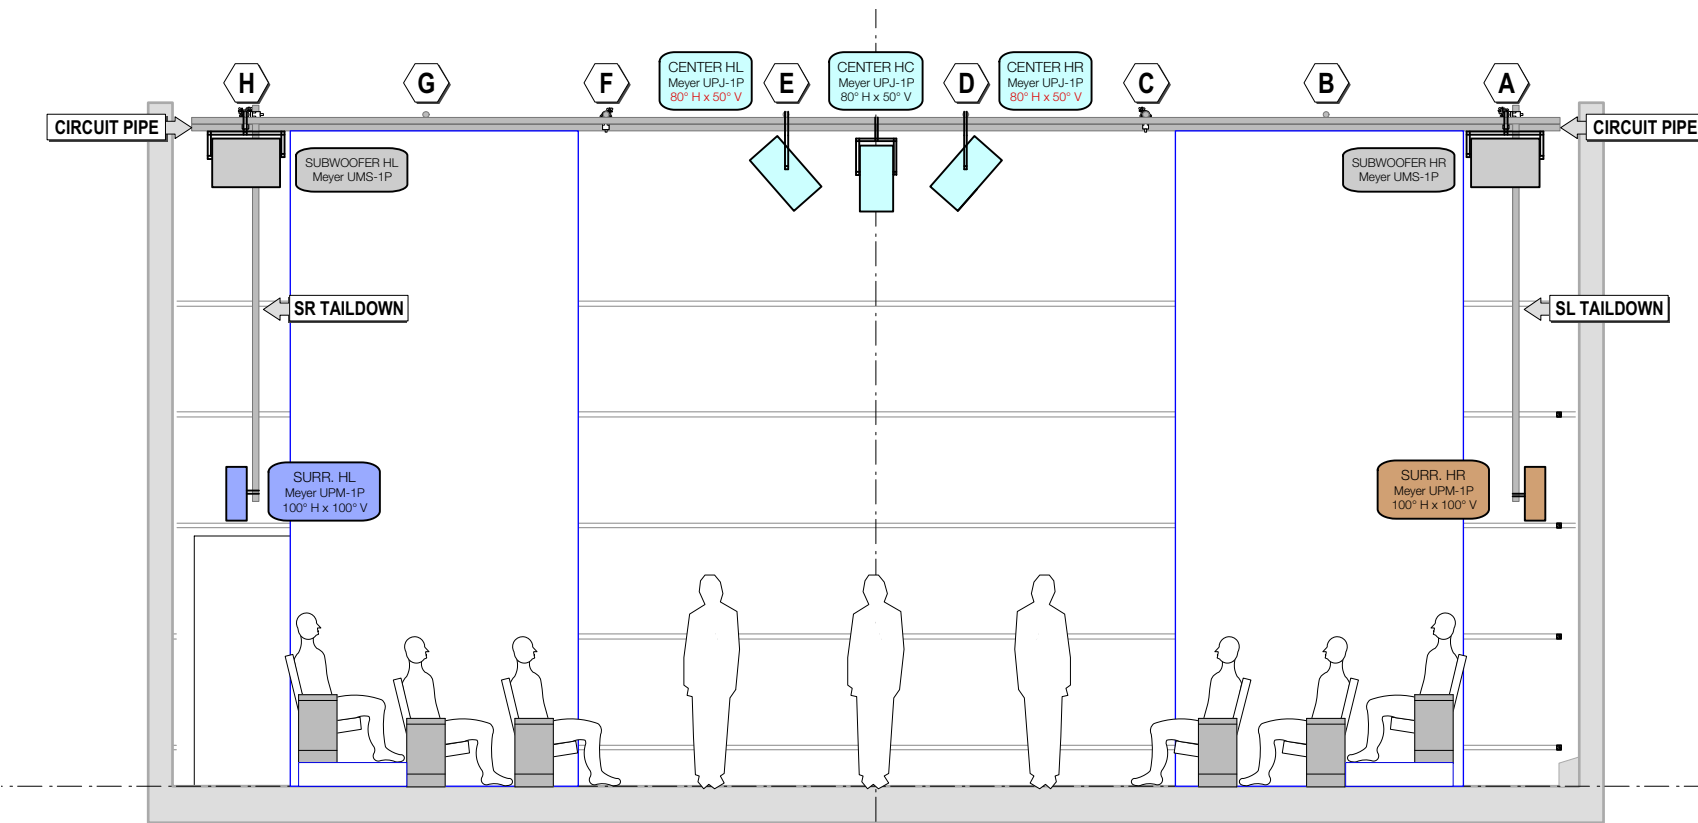

2 Front Elevation

- NOTES:**
- ALL LOUSPEAKERS HUNG FROM PIPE GRID EXCEPT FOR SURR. SPEAKERS AND TELEVISION FX MM-4.
 - VERTICAL TILT ANGLES AS FOLLOWS:
 CENTER HL - 48.56° DOWN TILT
 CENTER HR - 48.56° DOWN TILT
 CENTER HC - 33.68° DOWN TILT
 CENTER REAR - 36.0° DOWN TILT
 - ALL SPEAKERS MOUNTED HORN DOWN
 - MAIN AUDIO CABLE PATH RUNS ALONG PIPE 'C'
 - XTA ROUTING:
 INPUTS
 Ch. A - Center
 Ch. B - Subs
 Ch. C - Rear HC
 Ch. D - N/A
 OUTPUTS
 Ch. 1 - Center HL
 Ch. 2 - Center HR
 Ch. 3 - Center HC
 Ch. 4 - Subwoofer HL
 Ch. 5 - Subwoofer HR
 Ch. 6 - Rear HC
 - QLAB ROUTING:
 Q1 - Center Cluster
 Q2 - Surr. HL
 Q3 - Surr. HR
 Q4 - Surr. Rear HL
 Q5 - Surr. Rear HR
 Q6 - Surr. Rear HC
 Q7 - Subwoofer
 Q8 - Spare
 Q9 - Television FX
 Q10 - FX (Reverb)

SOUND PLOT
TAKE THE CAR

DIRECTING ASSISTANT
PROJECT #3



REV	REVISION	DATE
REV	REVISION	DATE
REV	REVISION	DATE
REV	REVISION	DATE
REV	REVISION	DATE
S4	DA3 - UPDATED SECT. VIEW	07/05/2015
S3	DA3 - TAKE THE CAR	07/03/2015
S2	2015 SEASON REP CLEAN	06/30/2015
S1	2015 SEASON REP	06/23/2015
REV	REVISION	DATE



Take the Car

PTP
PROFESSIONAL TRAINING PROGRAM at WTF
DIRECTING STUDIO
82 CENTER FOR THEATRE & DANCE
1000 MAIN ST., WILLIAMSTOWN, MA

WILLIAMSTOWN THEATRE FESTIVAL
PRESENTS
TAKE THE CAR
DIRECTOR OF PTP . . . JASON M'DOWELL GREEN
DIRECTED BY . . . BEN FERBER
SOUND DESIGN BY . . . JEFF SHERWOOD
LIGHTING BY . . . MIRIAM MICHAELS
ASST. LD . . .
PRODUCTION ELECTRICIAN . . . BRAD GRAY
MASTER ELECTRICIAN . . . ZACHARY HEFFNER
SCENERY BY . . . ALEX PETERSON
COSTUMES BY . . . ROBIN STEGMAN

SOUND DEPARTMENT
AUDIO SUPERVISOR. . . BEN TRUPPIN-BROWN
D.S. SOUND MOM. . . COLLIN BARNUM
D.S. SOUND AUNT. . . PATRICK LACHANCE
P.O. BOX 517, WILLIAMSTOWN, MA 01267
T: (413) 597-3416 | F: (413) 597-3358
E: sound@wtfestival.org

SOUND DESIGNER
JEFF SHERWOOD
WILLIAMSTOWN THEATRE FESTIVAL
1000 MAIN STREET
WILLIAMSTOWN, MA 01267
JRSHERW@GMAIL.COM

THIS DRAWING REPRESENTS VISUAL CONCEPTS AND CONSTRUCTION SUGGESTIONS ONLY. IT DOES NOT REPLACE THE KNOWLEDGE AND ADVICE OF A LICENSED STRUCTURAL ENGINEER. THE DESIGNER IS UNQUALIFIED TO DETERMINE THE STRUCTURAL APPROPRIATENESS OF THIS DESIGN AND WILL NOT ASSUME RESPONSIBILITY FOR IMPROPER ENGINEERING OR USE.

SCALE:	3/16"=1'-0"	PLATE
DRAWN BY:	JG, DS, J.SHERWOOD	2 of 2
CREATED:	June 21, 2015	
REVISED:	6/30/15 11:35:12 PM	
FILE:	WTF 2015 DS Rev54-DA3.vwx	

3/16" SECTION/EL